


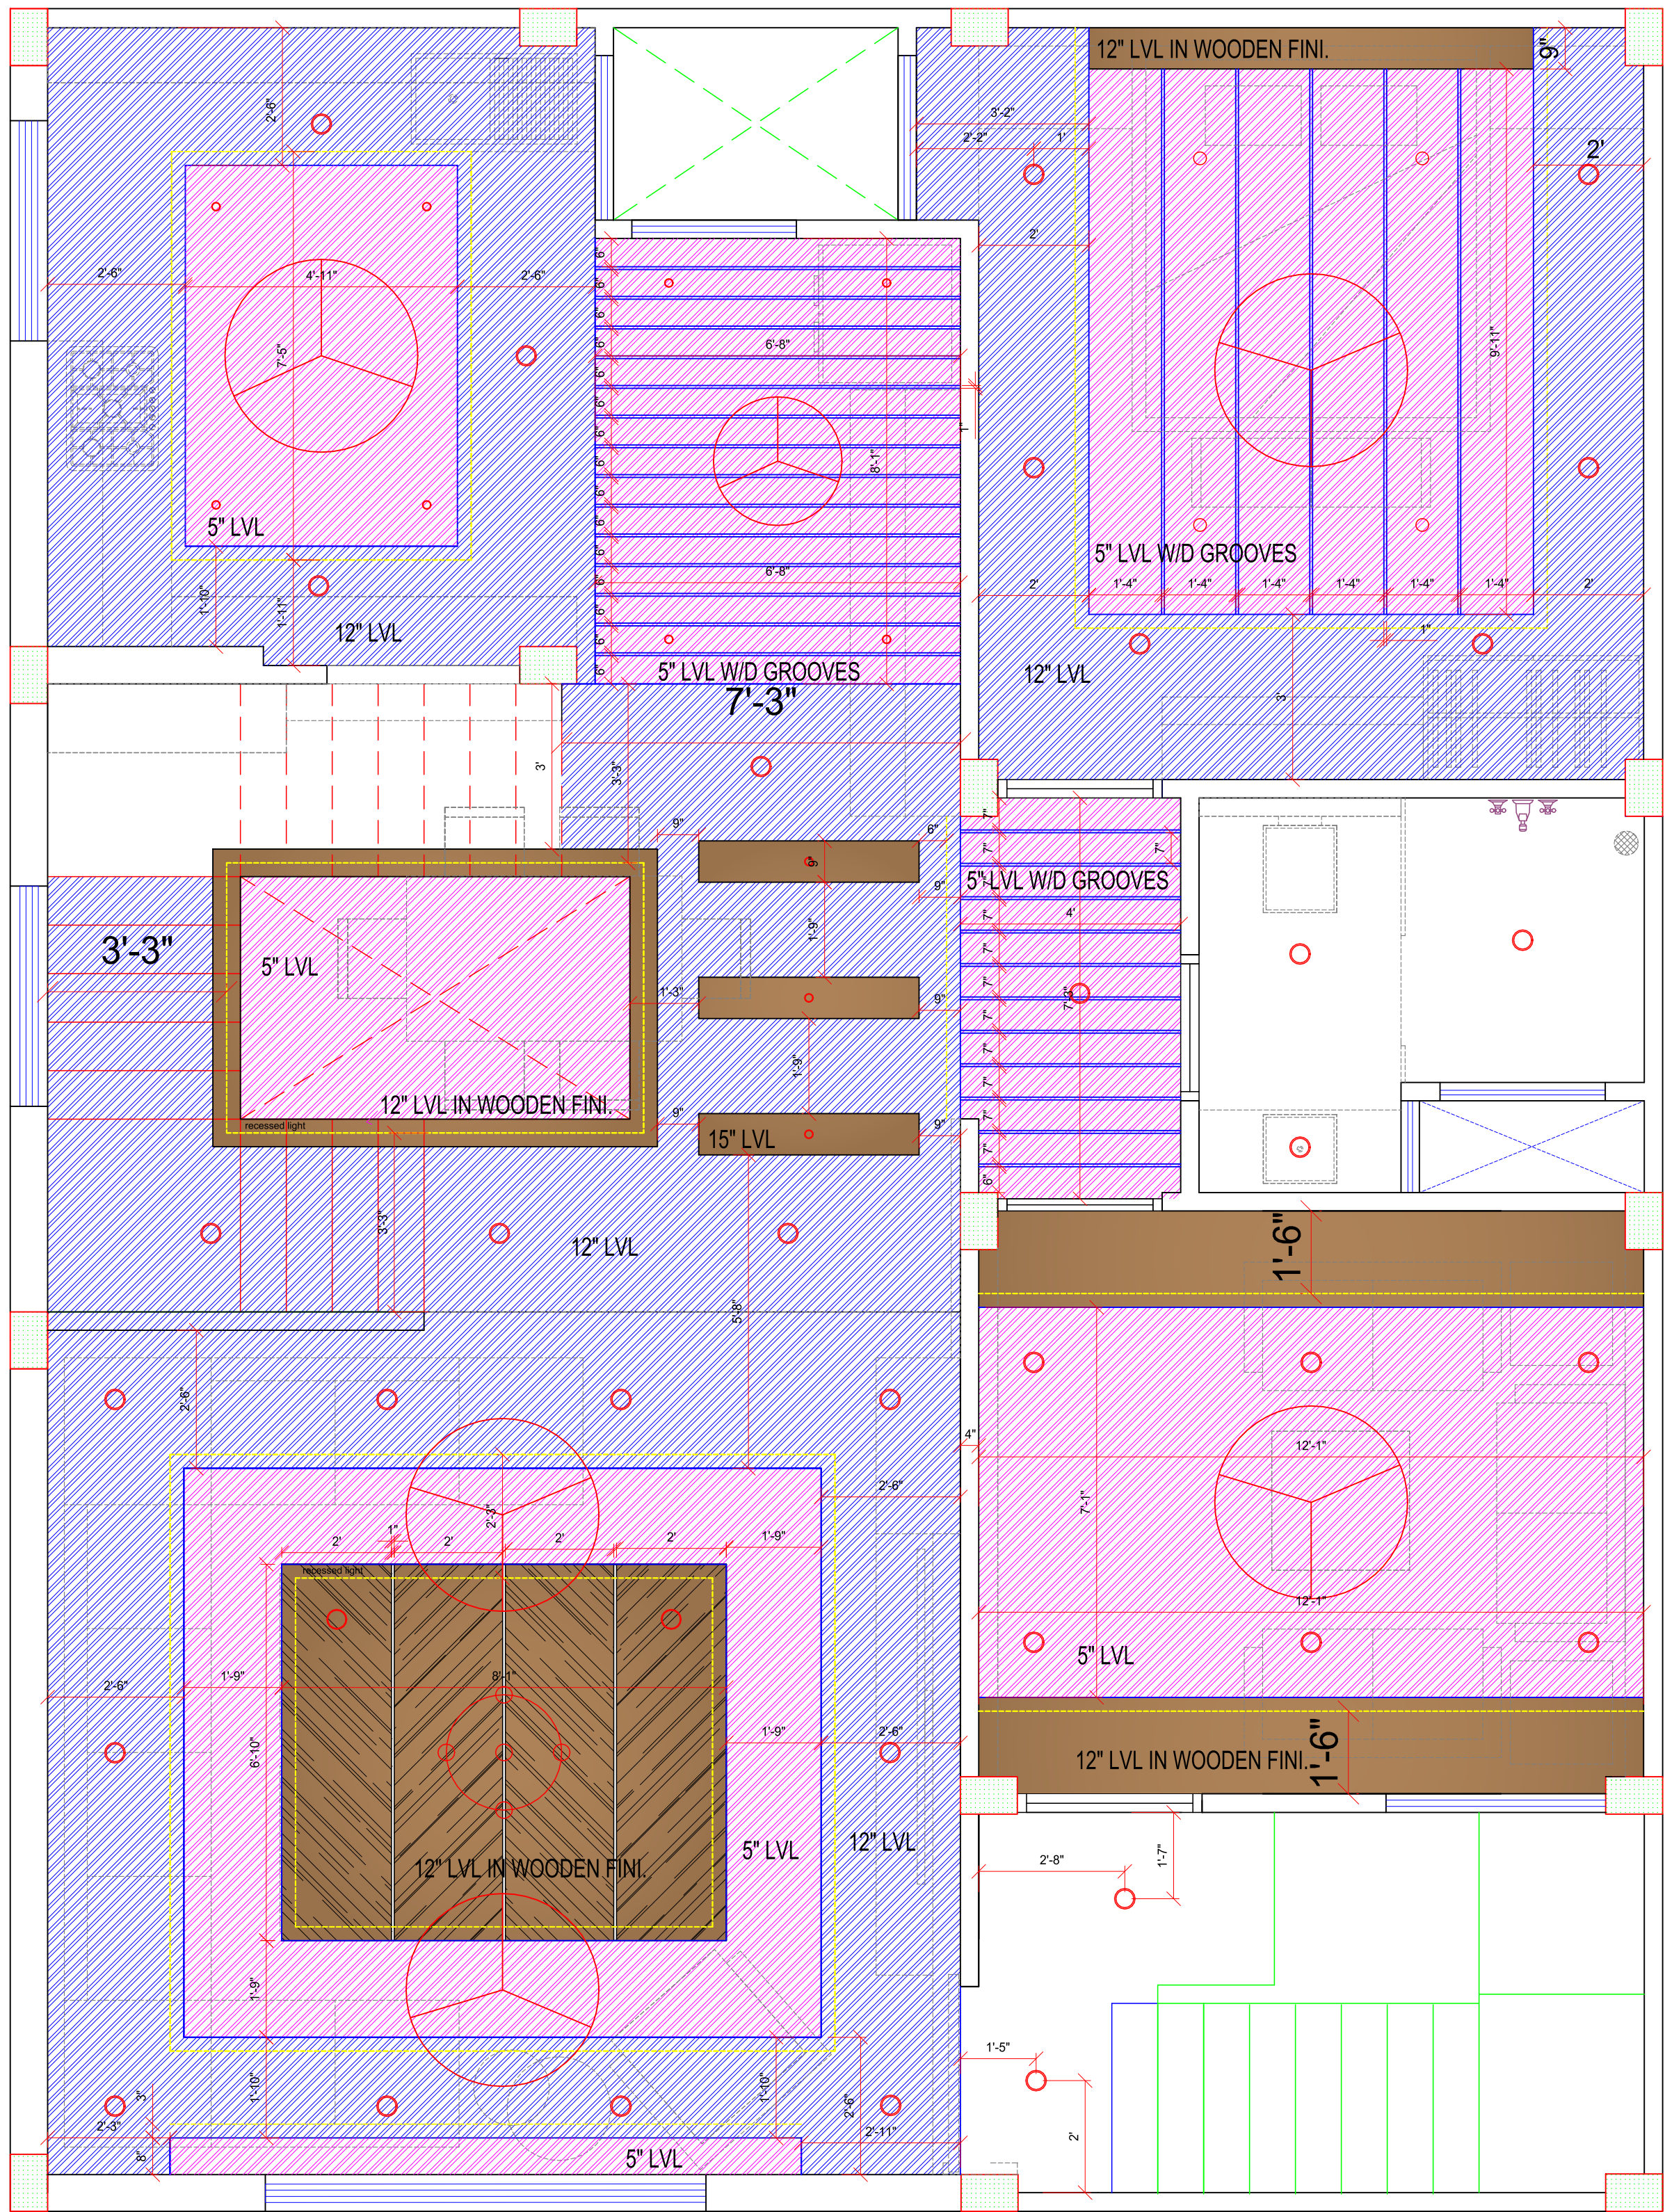

FIRST FLOOR FALSE CEILING W/D ELECTRICAL LAYOUT PLAN

CLIENT	DHEERAJ JI	DRG. NO.	DC-186-CL-01
PROJECT	RESIDENTIAL G+2	SIZE	A3 (SHEET-2)
LOCATION	INDORE	DATE	05/03/2021
FIRST FLOOR CELLING PLAN		DESIGN BY	SHRIKANT PAL
DC DREAM CREATION ENGINEER & ARCHITECTS RESIDENTIAL, COMMERCIAL, INDUSTRIAL	Add.:- 1A, First Floor Manoramaganj Near Gita Bhawan Square, Behind Vishesh Hospital, Indore (M.P.) e-mail: shrik.pal@gmail.com Cell: 0-9827389978, 0-9993089978		Rev.
			0