




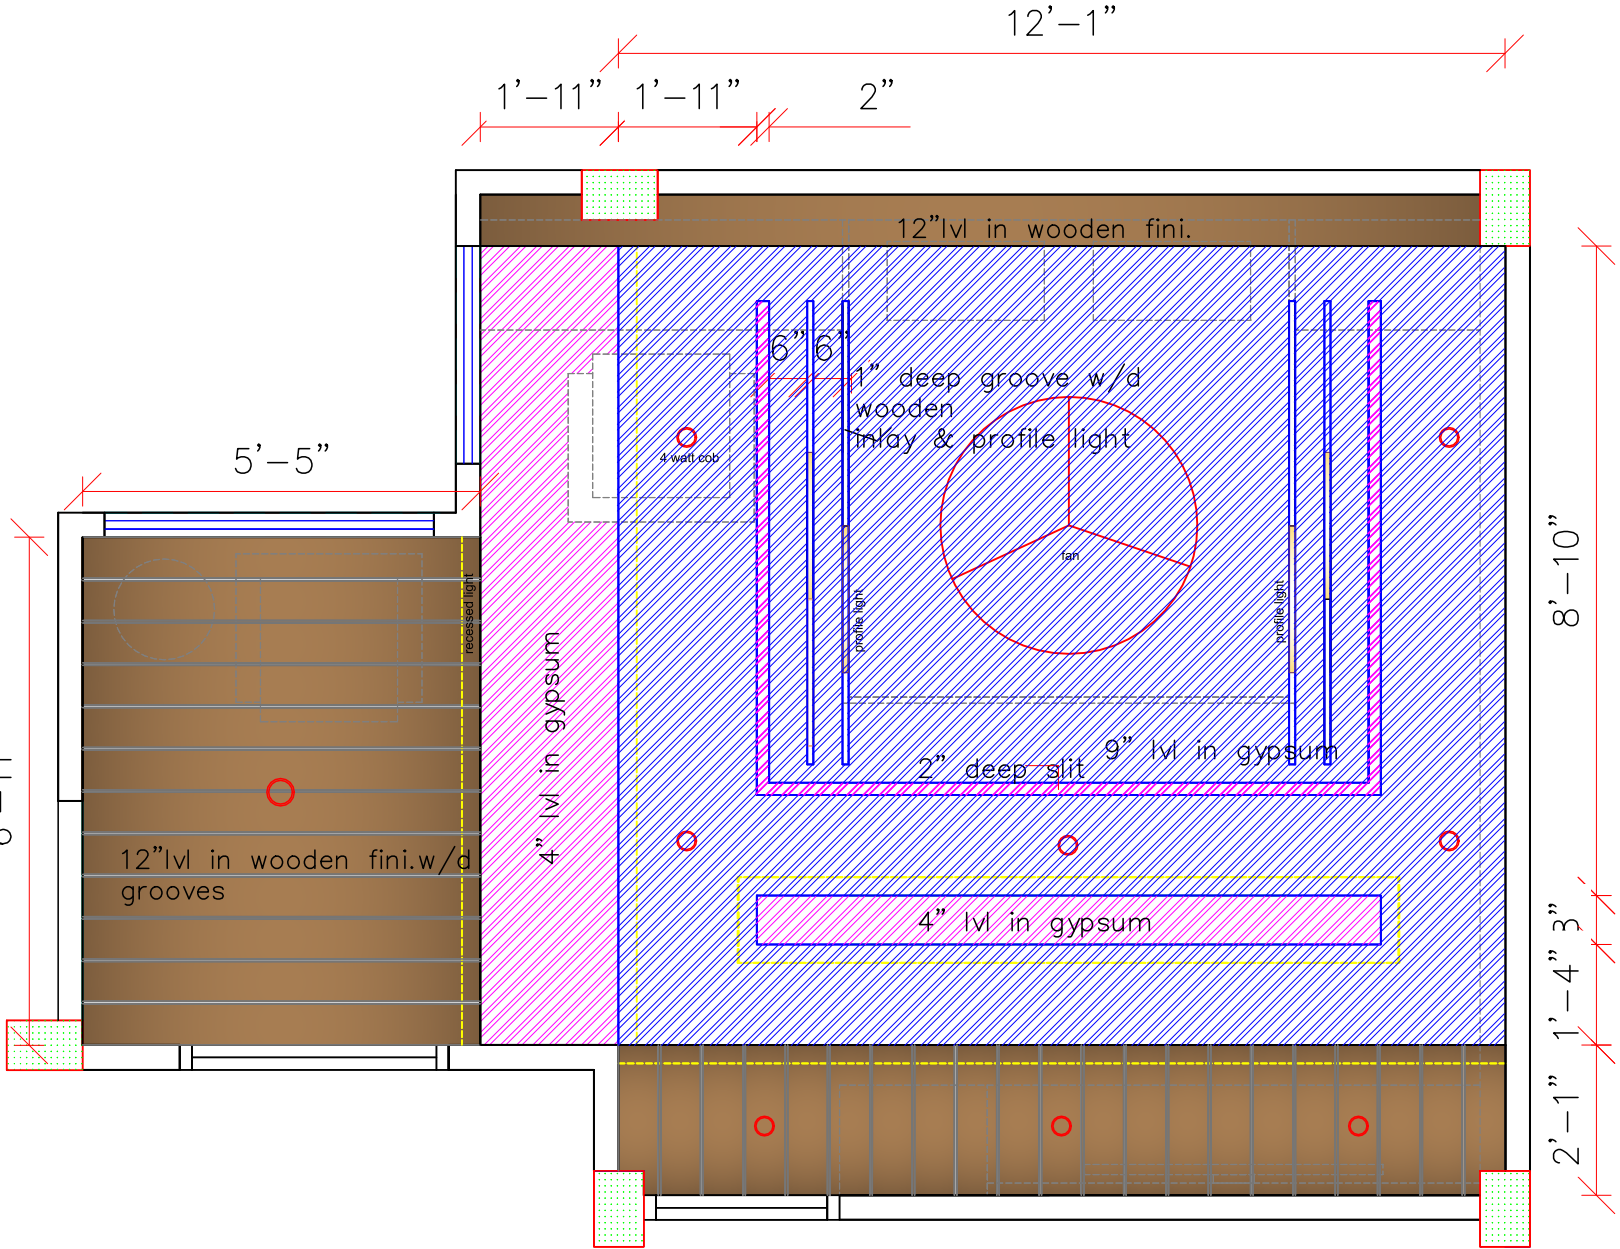


MASTER ROOM CEILING PLAN

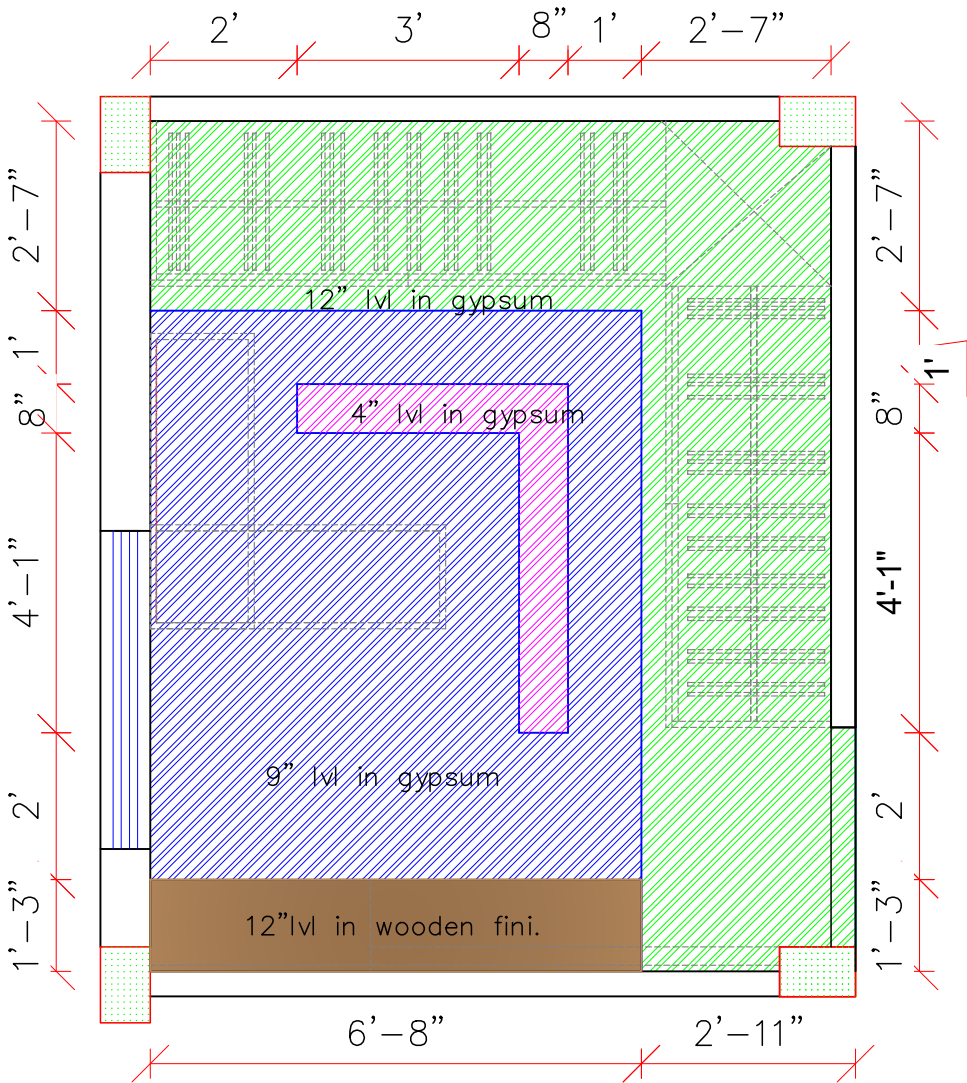

CLOSET CEILING PLAN

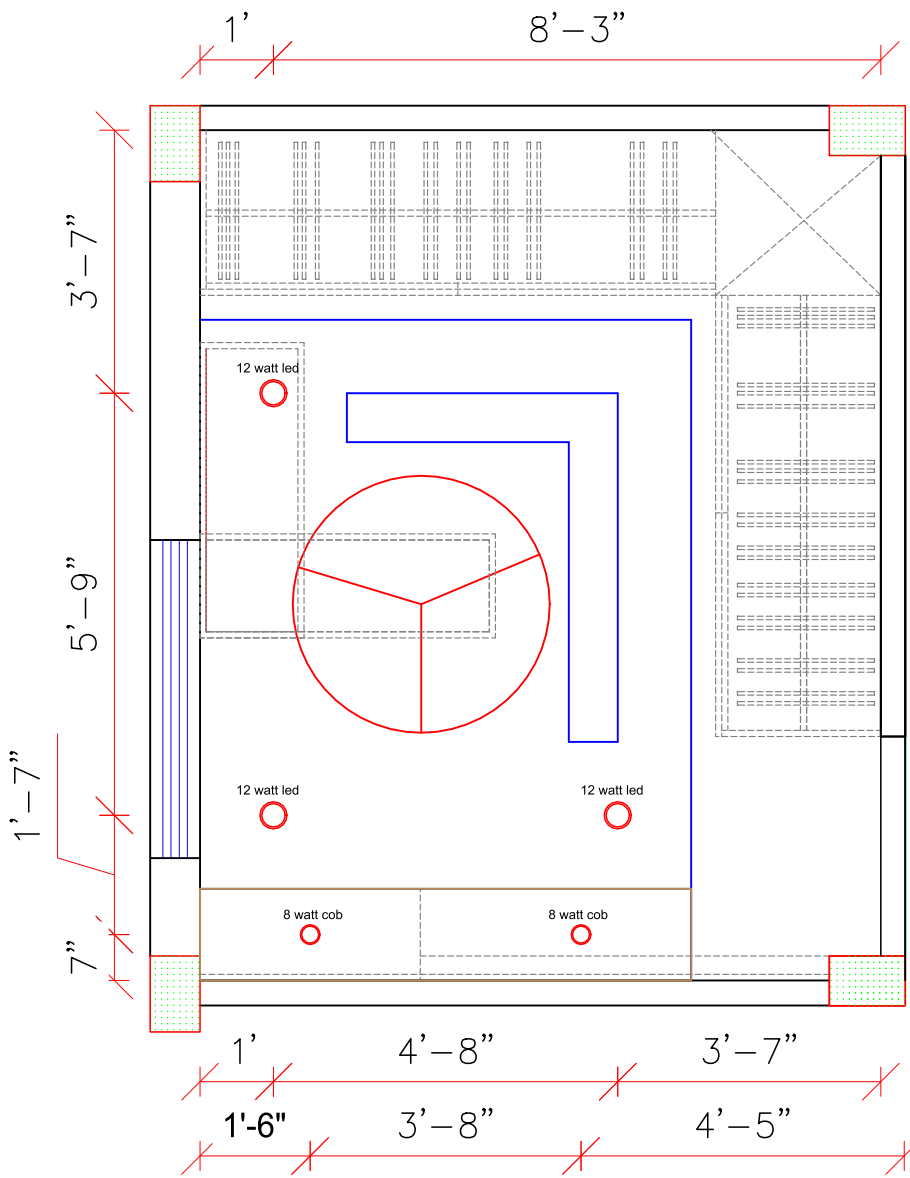


CLOSET ELECTRICAL PLAN

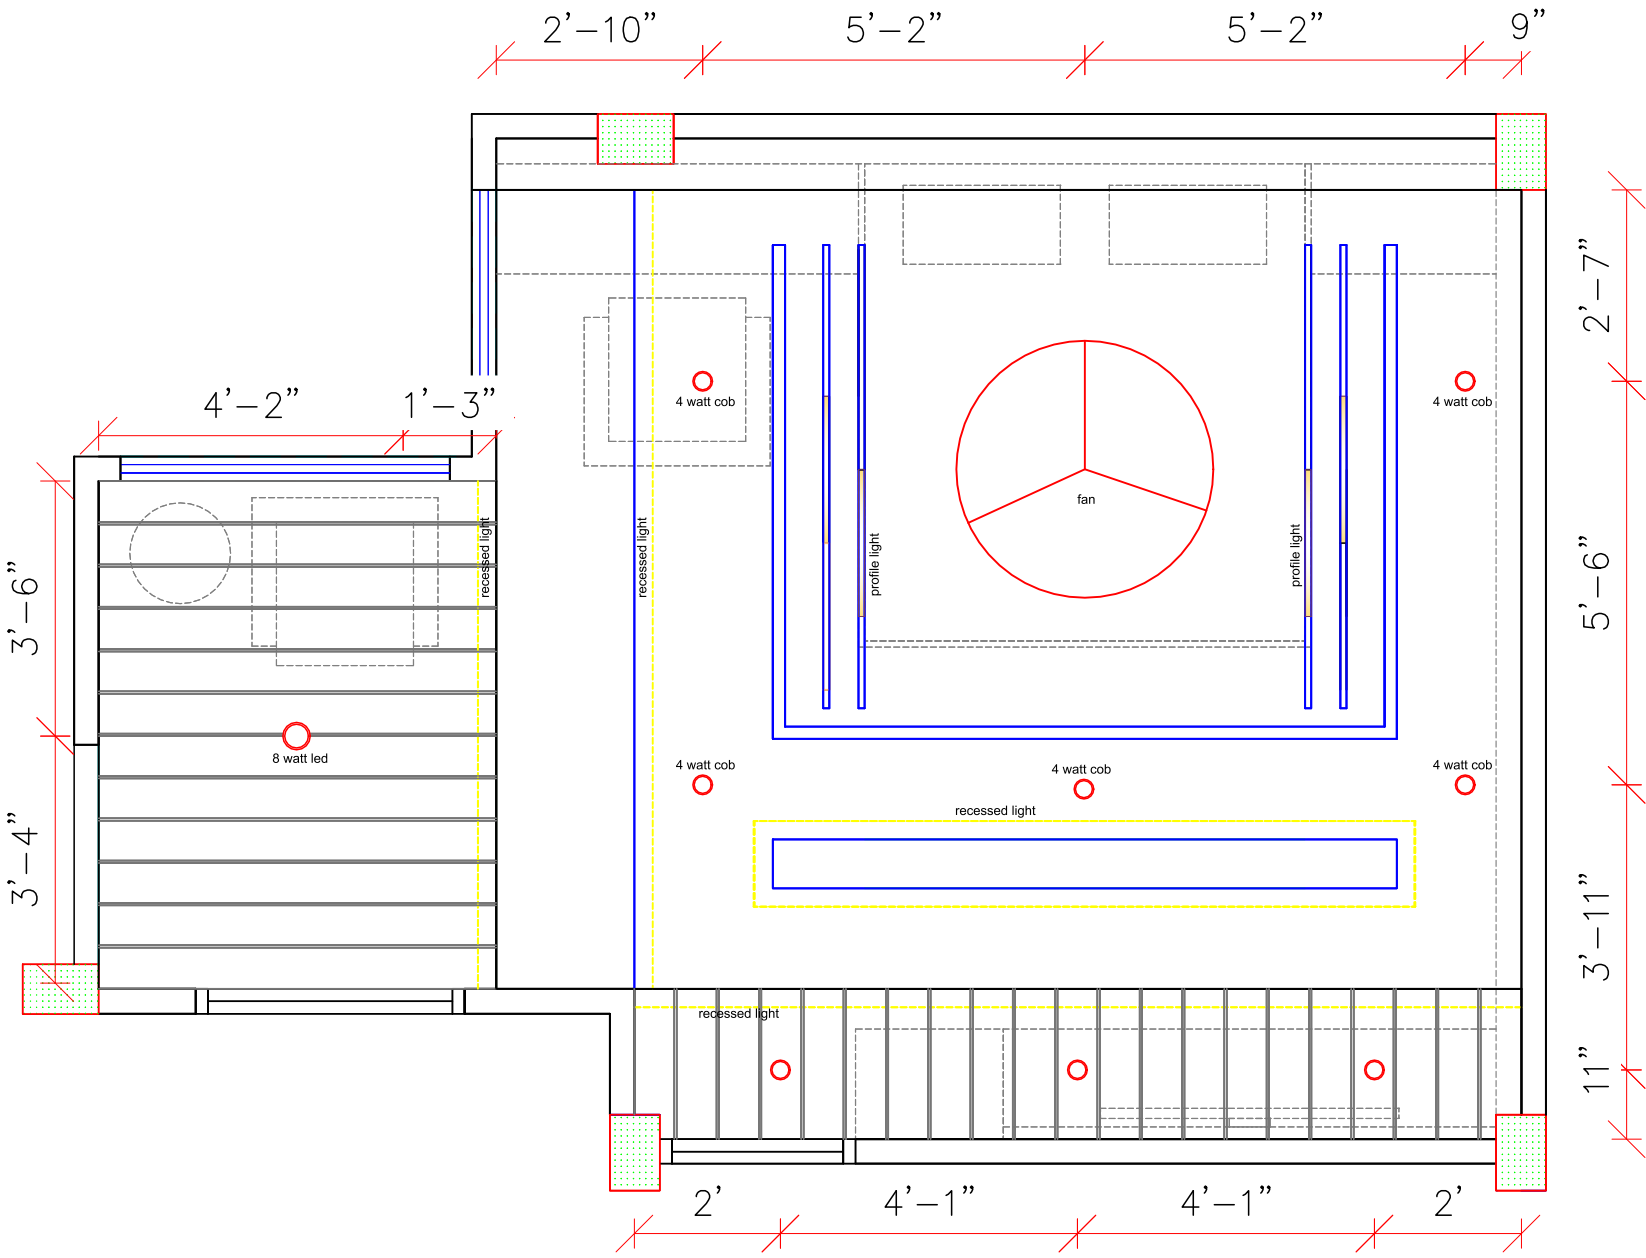

MASTER ROOM ELECTRICAL PLAN

SECOND FLOOR

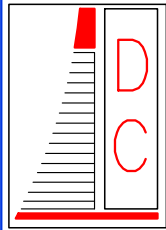CLIENT	DHEERAJ JI	DRG. NO.	DC-186-EL-023
PROJECT	RESIDENTIAL G+2	SIZE	A3 (SHEET-1)
LOCATION	INDORE	DATE	06/03/2021
MASTER ROOM		DESIGN BY	SHRIKANT PAL
 DREAM CREATION ENGINEER & ARCHITECTS RESIDENTIAL, COMMERCIAL, INDUSTRIAL		Add.: 1A, First Floor Manoramaganj Near Gita Bhawan Square, Behind Vishesh Hospital, Indore (M.P.) e-mail: shrik.pal@gmail.com Cell: 0-9827389978, 0-9993089978	
		Rev.	0