




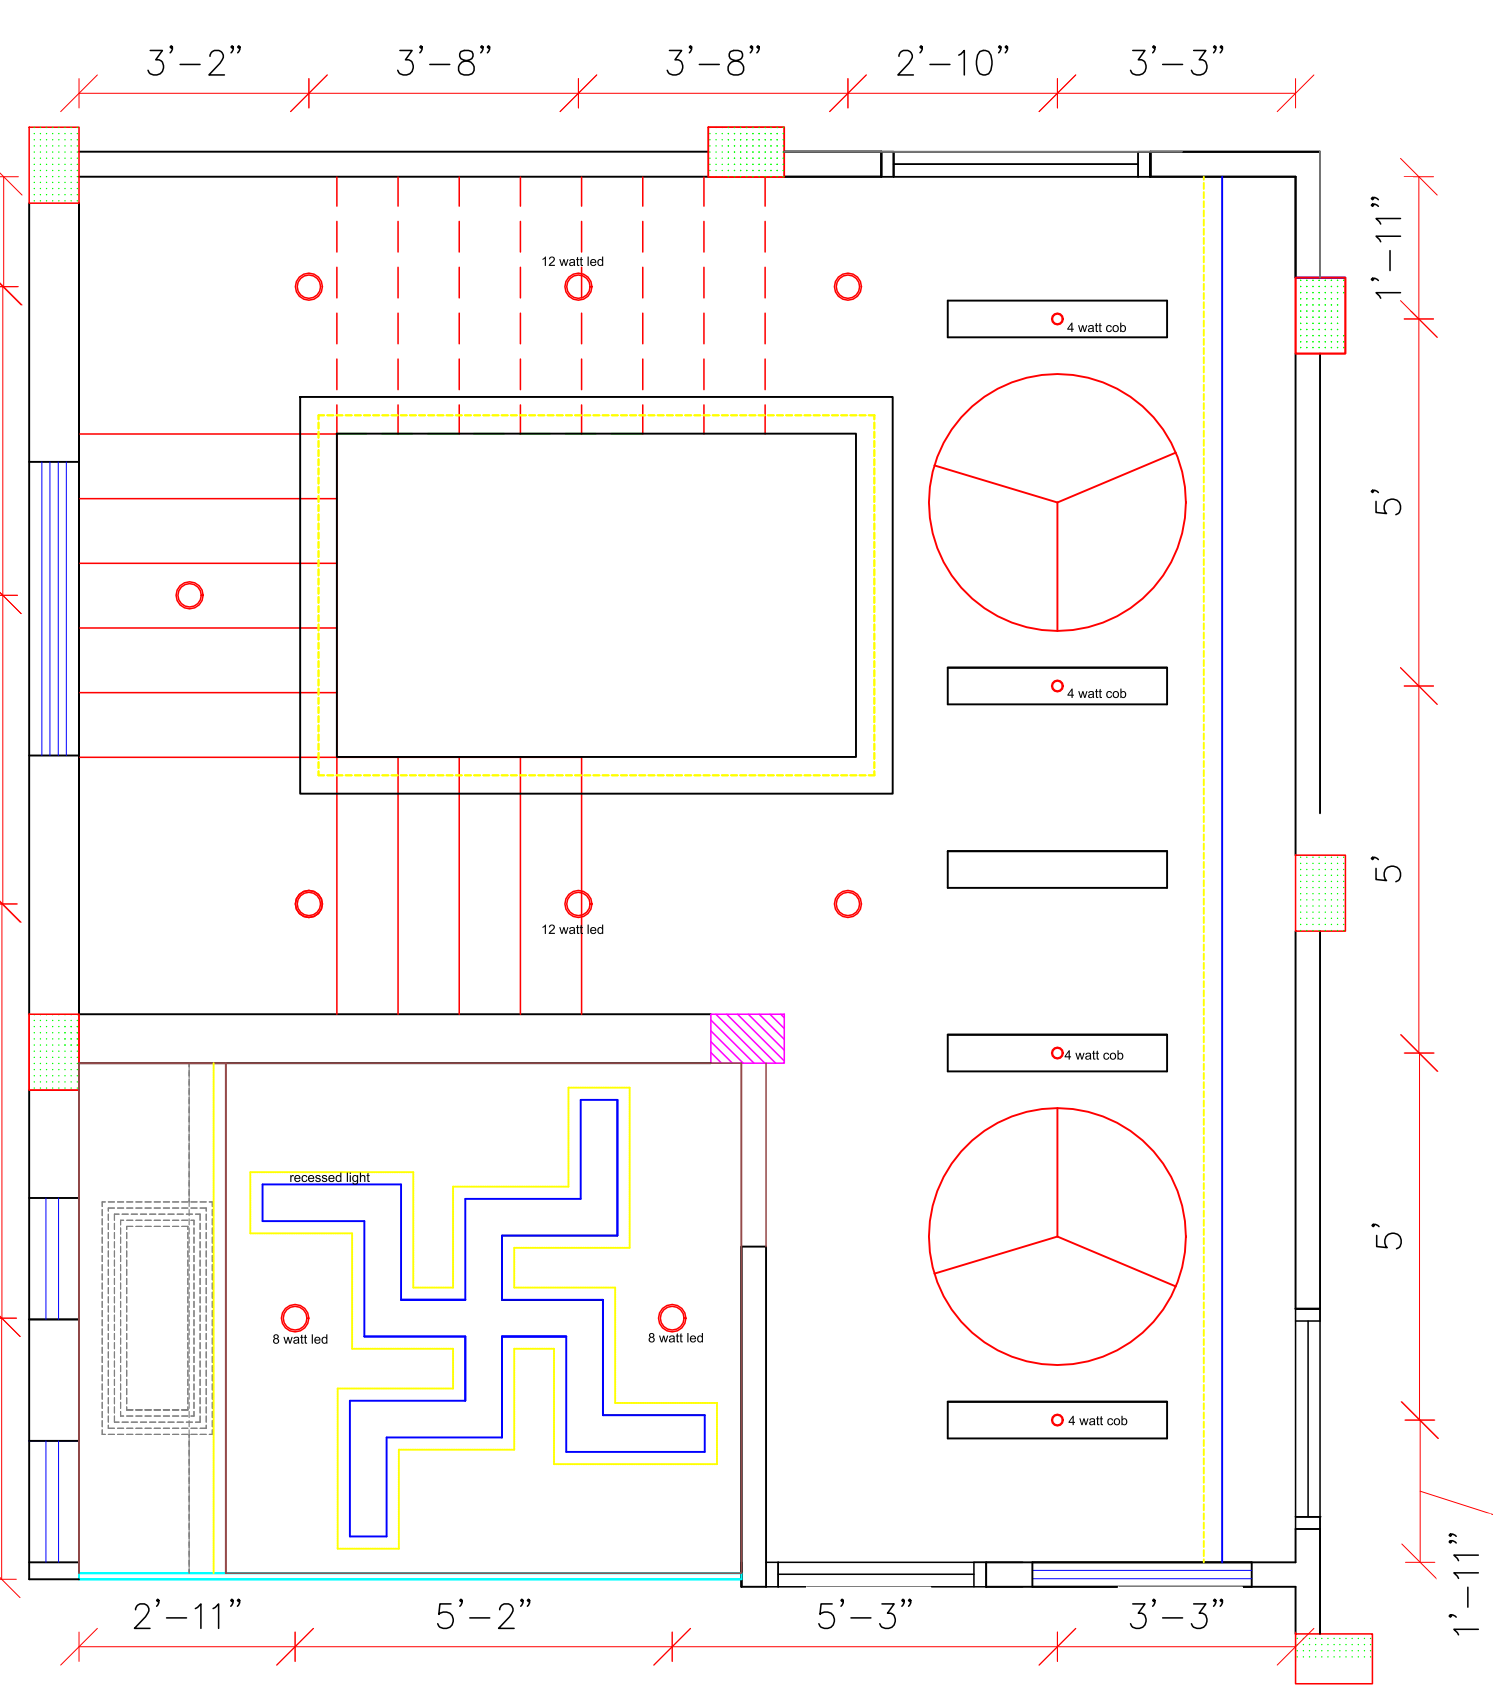


LOUNGE & MANDIR ELECTRICAL PLAN

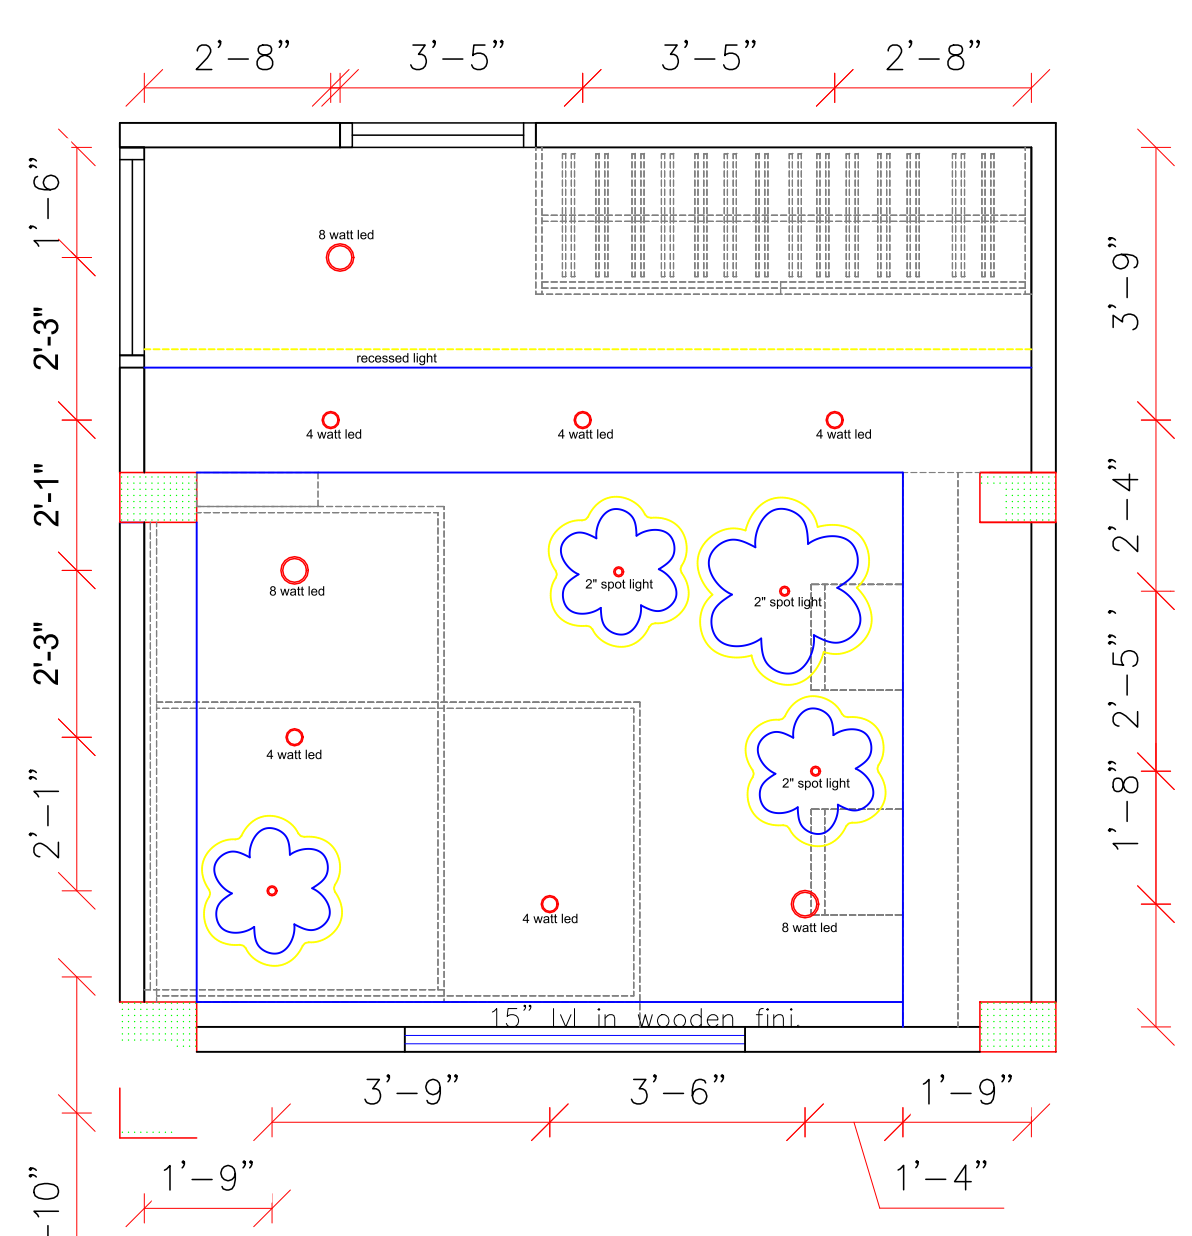

KIDS ROOM ELECTRICAL PLAN

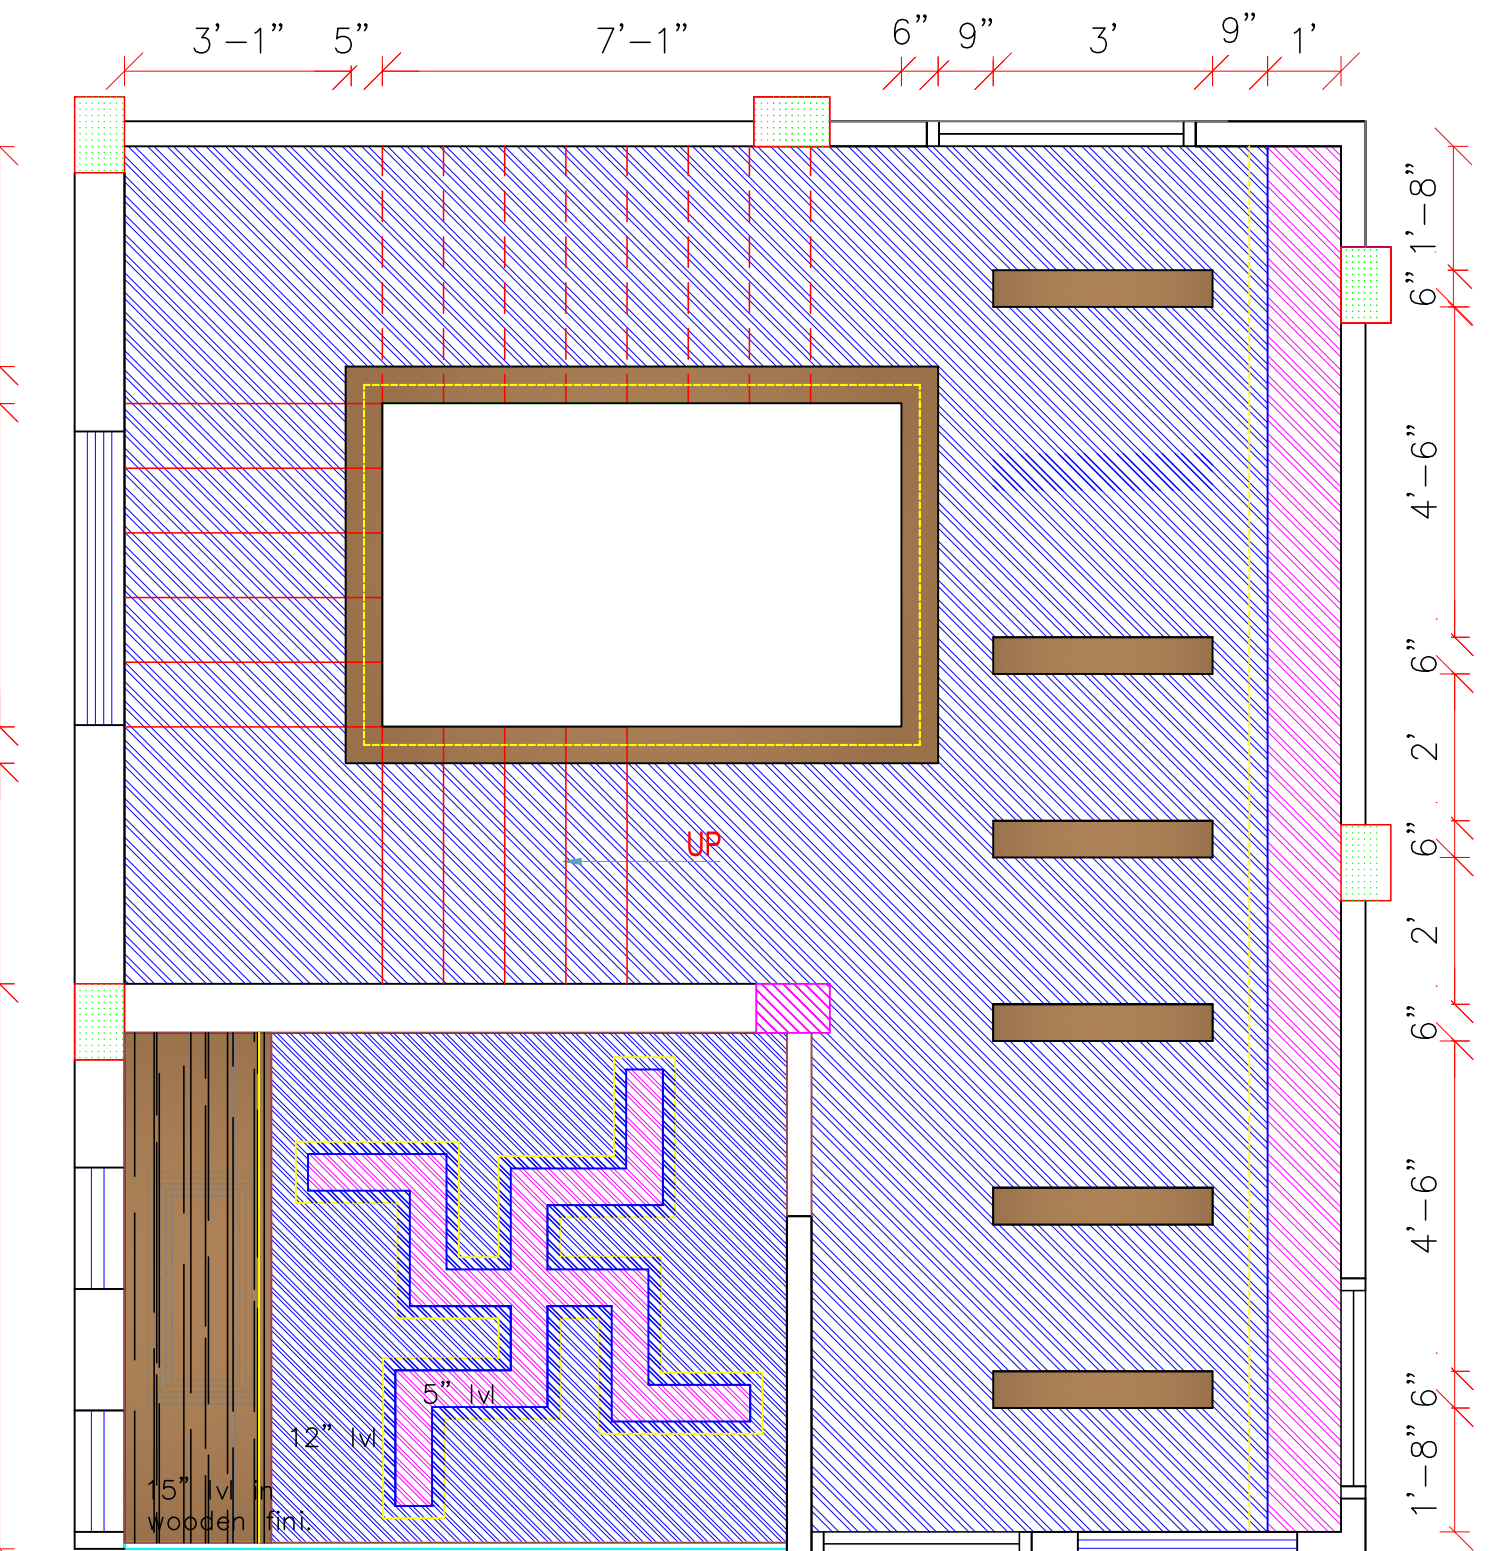


LOUNGE & MANDIR CEILING PLAN

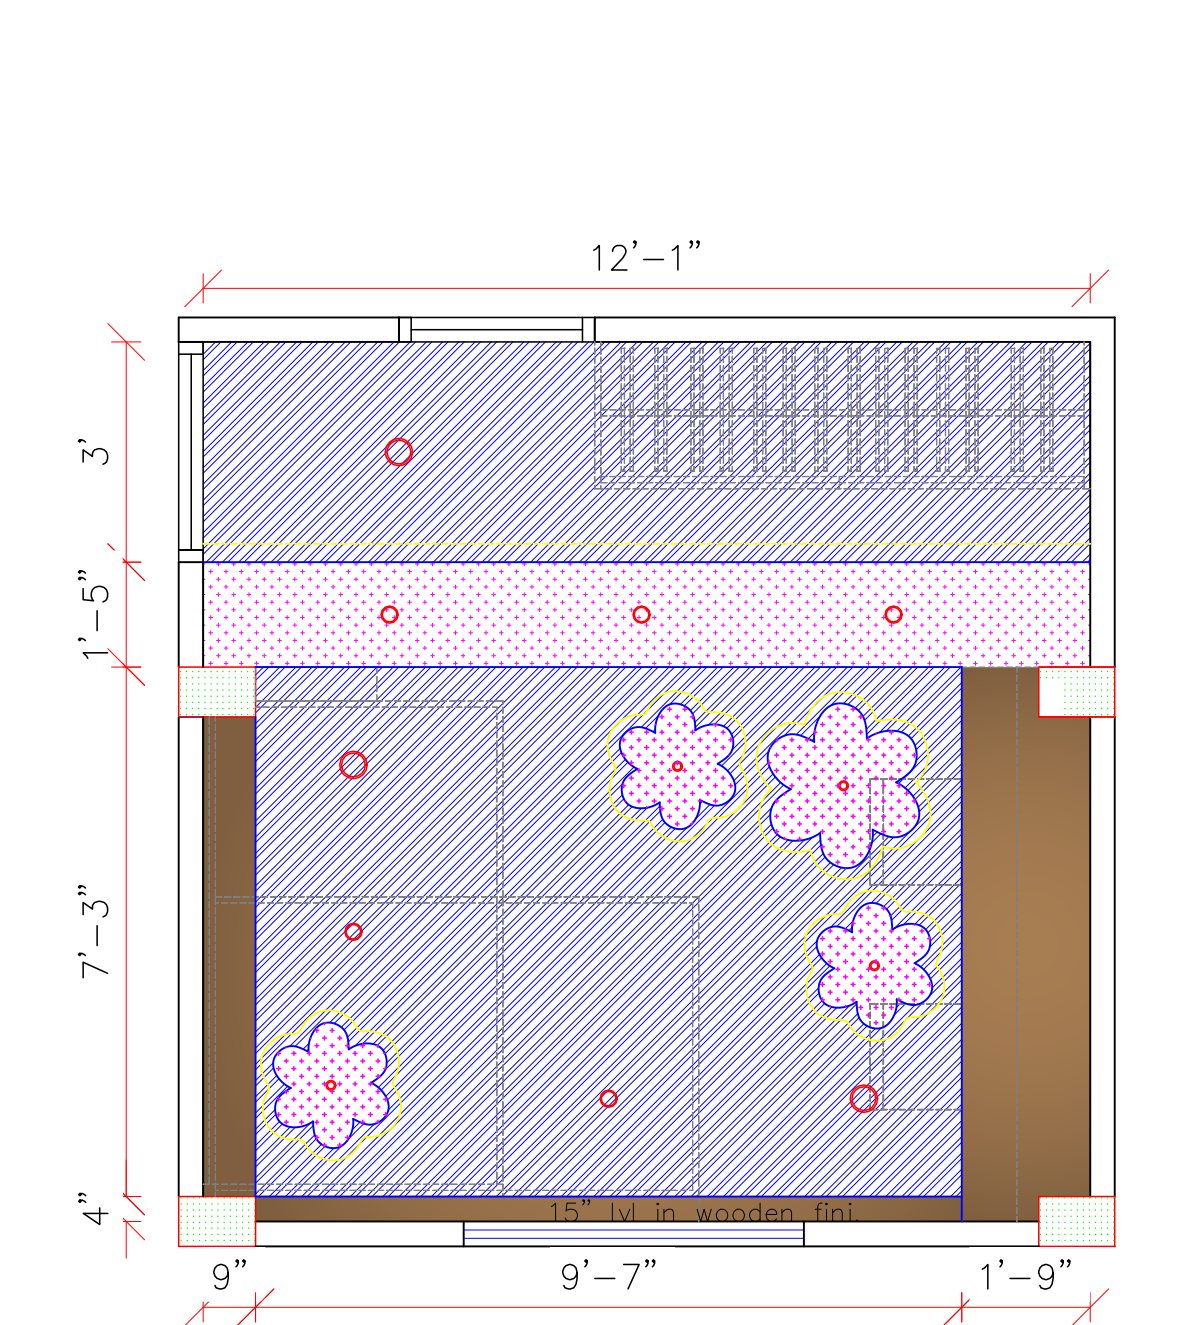

KIDS ROOM CEILING PLAN

SECOND FLOOR

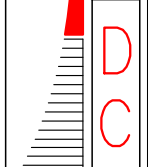CLIENT	DHEERAJ JI	DRG. NO.	DC-186-EL-022	
PROJECT	RESIDENTIAL G+2	SIZE	A3 (SHEET-1)	
LOCATION	INDORE	DATE	06/03/2021	
KIDS ROOM AND LOUNGE AREA		DESIGN BY	SHRIKANT PAL	
	DREAM CREATION ENGINEER & ARCHITECTS		Add.-: 1A, First Floor Manoramaganj Near Gita Bhawan Square, Behind Vishesh Hospital, Indore (M.P.) e-mail: shrik.pal@gmail.com Cell: 0-9827389978, 0-9993089978	Rev.
				0
	RESIDENTIAL, COMMERCIAL, INDUSTRIAL			