



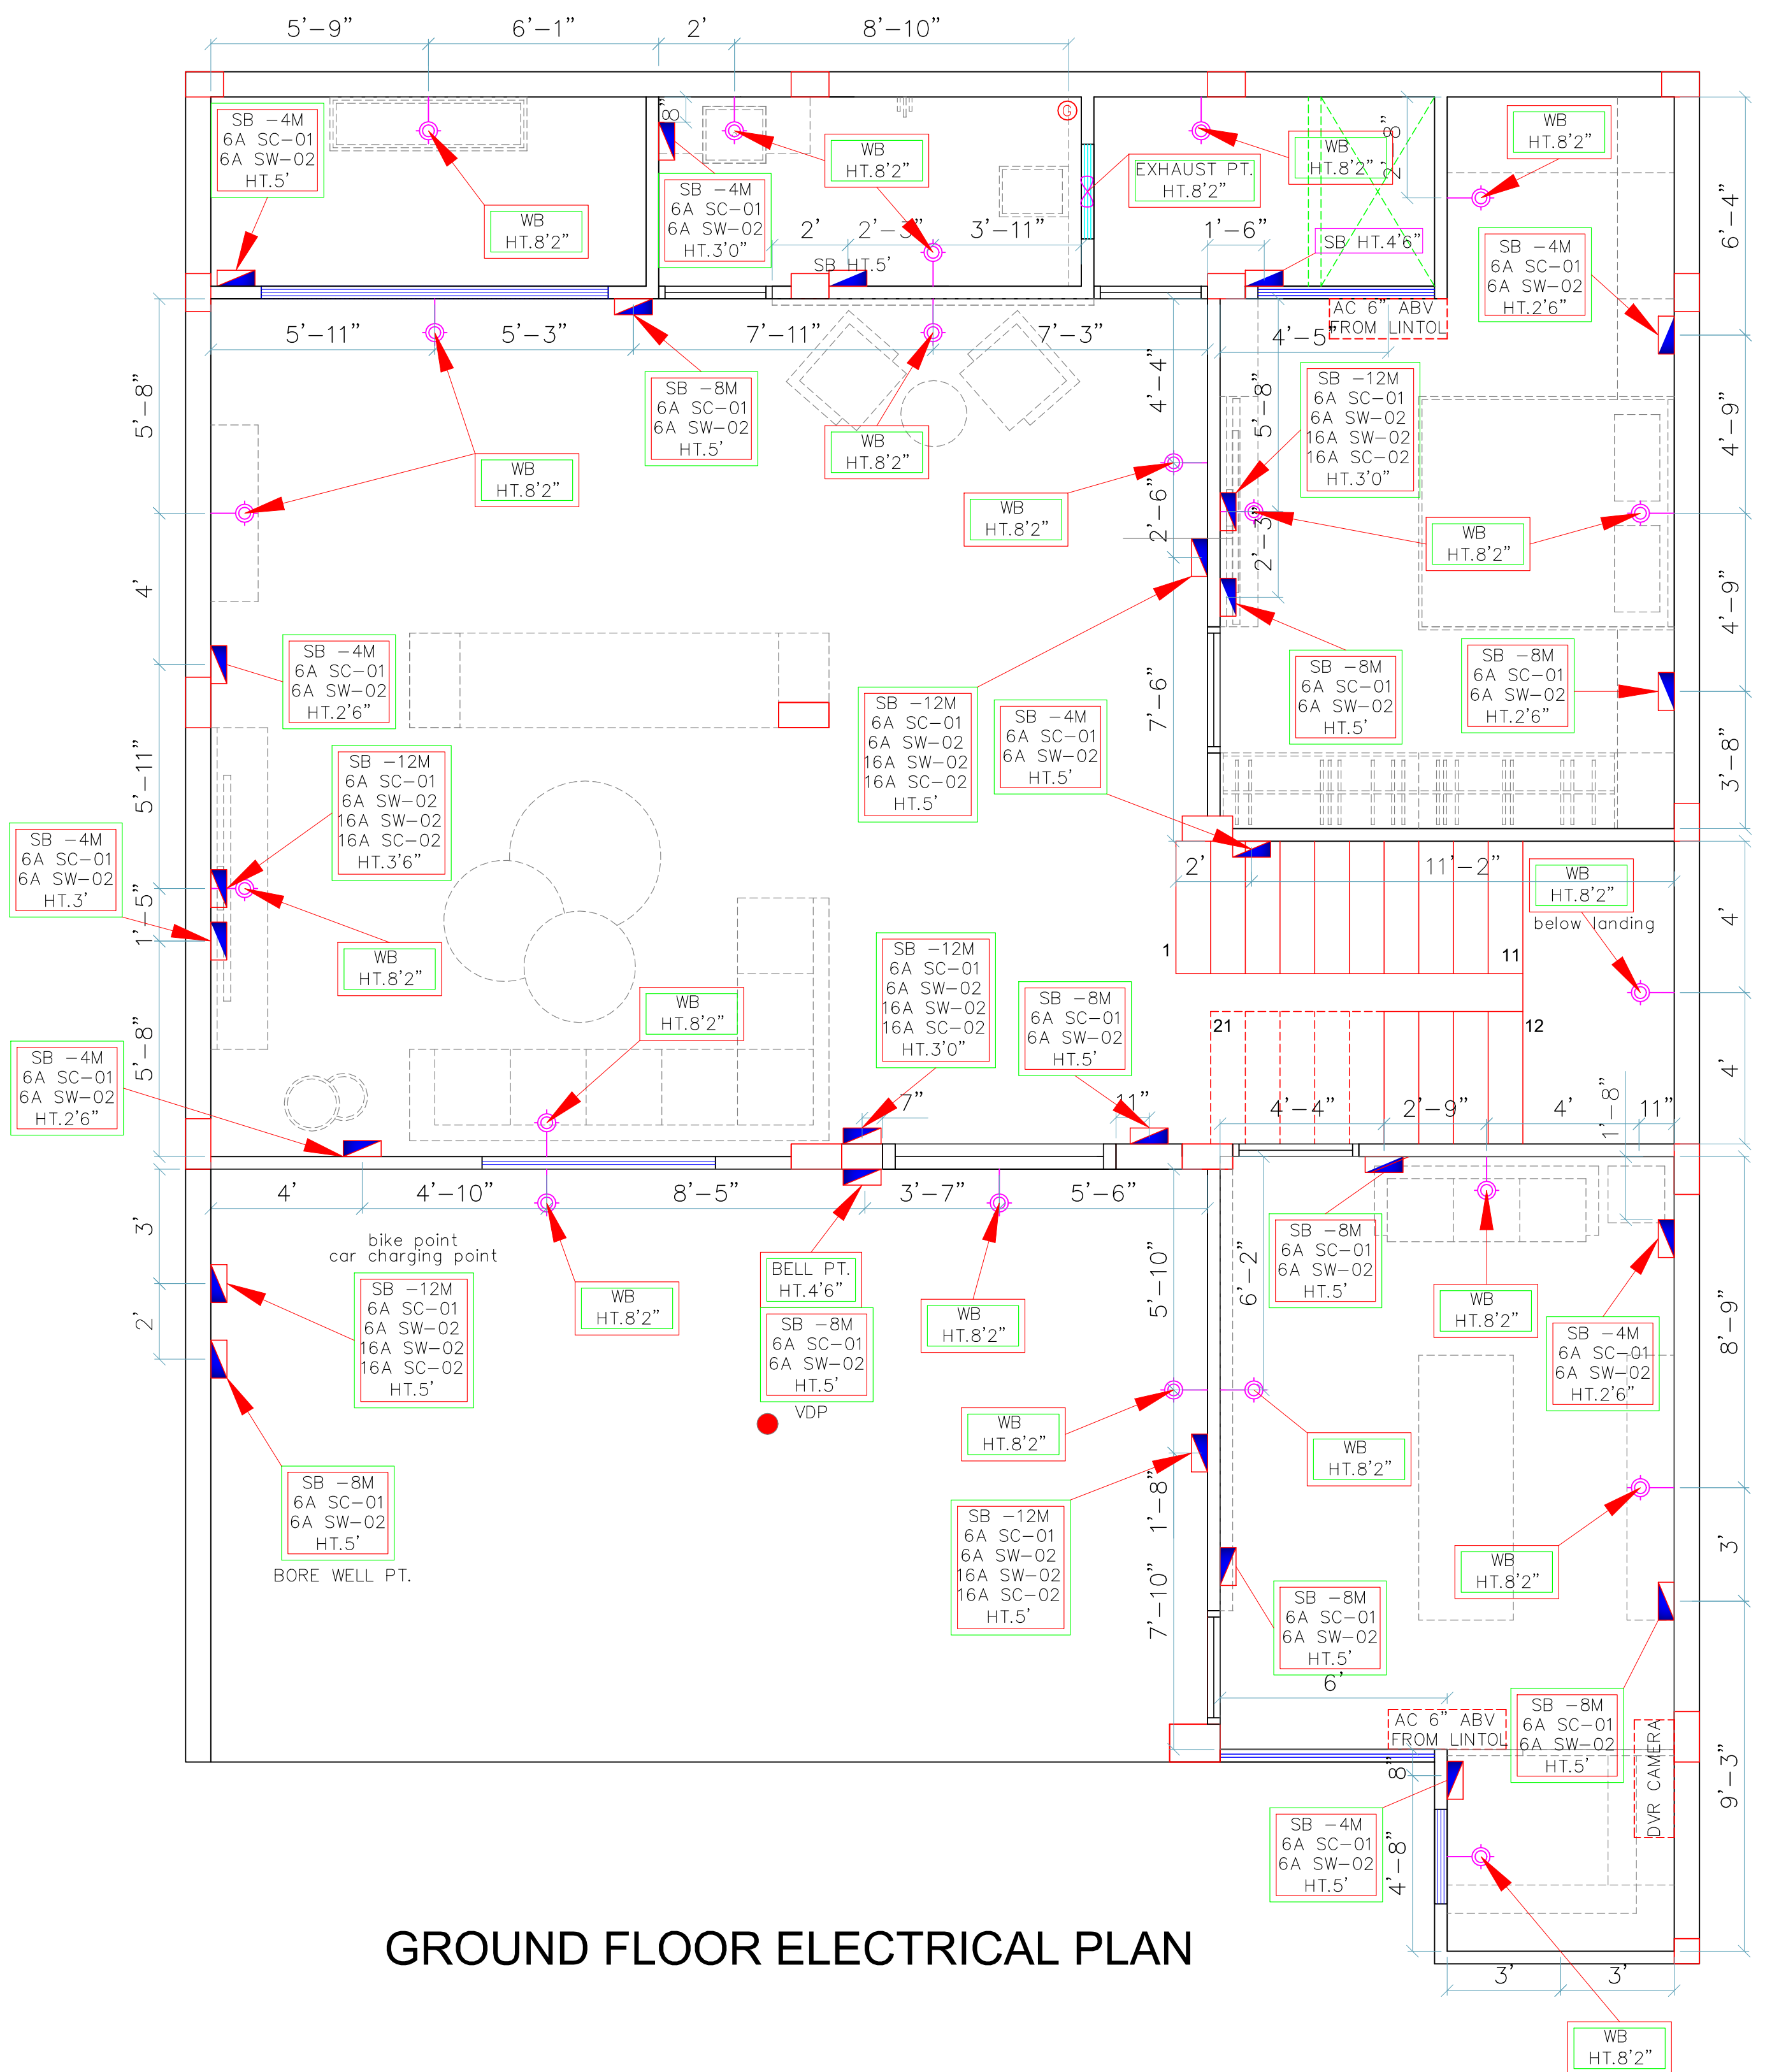

GROUND FLOOR ELECTRICAL PLAN

INVERTER LINE
CCTV LINE
WI FI LINE
SOLAR PANEL
HOME AUTOMATION
VIDEO DOOR PHONE

CLIENT	MR. SHIVMOHAN SHARMA JI	DRG. NO.	DC-202-EL-01
PROJECT	RESIDENTIAL G+2	SIZE	A3 (SHEET-1)
LOCATION	INDORE	DATE	28-07-2021
GROUND FLOOR ELECTRICAL PLAN		DESIGN BY	S.PAL

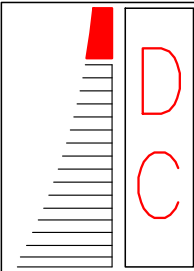

DREAM CREATION

ENGINEER & ARCHITECTS

RESIDENTIAL, COMMERCIAL, INDUSTRIAL

Add.- 1A, First Floor Manoramaganj
Near Gita Bhawan Square, Behind
Vishesh Hospital, Indore (M.P.)

e-mail: shrik.pal@gmail.com

Cell: 0-9827389978, 0-9993089978

Rev.

0